
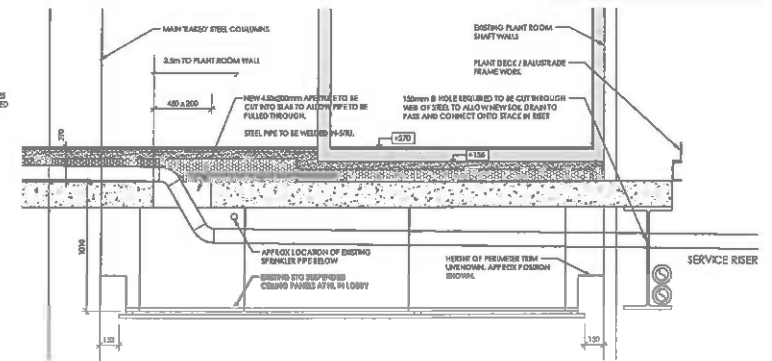


Fire Extinguisher and Fire Blanket Proposed Design

- FB** Fire Blanket 1.5m x 1.5m
- FX** 1no 2kg Co2 & 1no 6L Foam Fire Extinguisher - Excluding the Kitchens

Notes:
 Do Not Scale. Use only figured dimensions.
 All dimensions to be checked on the prior to construction.
 Any discrepancies to be resolved by the architect.
 All Copyright Reserved to Offisat Architects.

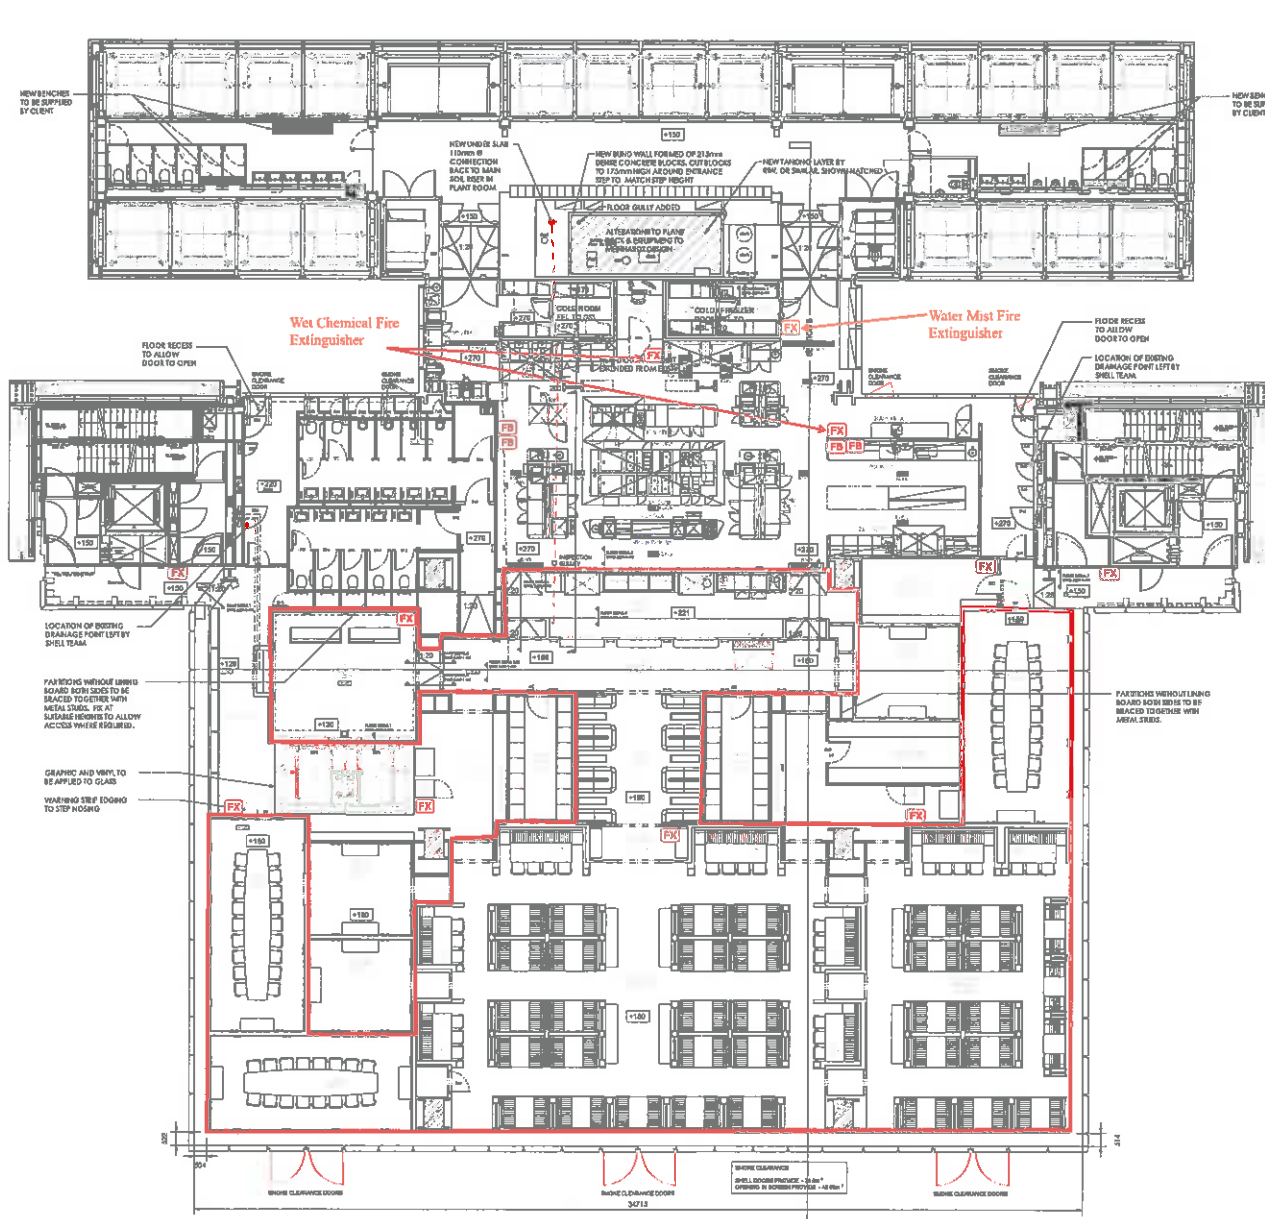

- O 20.06.17 LAB WALL AND FIRE OUTLET REMOVED.
- STP BETWEEN FLOOR & CLOAKROOM UPDATED.
- N 24.04.17 ELECTRICAL PLANT ROOM REVISIONS REVISED. CLOAK ROOM COOL RAIL & PATTERNS UPDATED.
- M 24.03.17 DOOR SEEP NOT UPDATED. NOTE ADDED FOR EXTRA PATTERNS & BEADING.
- L 22.04.17 CUPBOARD W/C AREA REVISED. DOOR ADDED FROM KITCHEN TO ESCAPE CORRIDOR. PLANT ROOM COLD RAIL ADDED. CLOAKROOM FLOOR LEVELS REVISED.
- 29.03.17 CUSTOMER W/C "BIBBY" SEATING CUT OUT/UPDATED.
- 20.03.17 POSITION OF KITCHEN COLD FREEZER ROOMS REVISED FOLLOWING KITCHEN LAYOUT UPDATE.
- 09.03.17 STAFF CHANGING BENCHES ADDED. REAR KITCHEN DRAIN CHANNELS BLOCKED. CLEARANCE CUT TO REMOVED CHEMICAL STORE.
- 10.02.17 KITCHEN LAYOUT UPDATED TO SET HALL NAME. NEW EQUIPMENT PLAN. NEW BAR STORE REVISED. POH OFFICE CHANGED.
- G 20.12.16 INTERNAL LAYOUT UPDATED TO SET REVISIONS OF PREVIOUS DESIGN.
- F 13.10.16 LANDSCAPED SUBMISSION. MISCOR REVISIONS TO BOH PATTERNS & BEAMER.
- E 07.10.16 DRINKS W/C CLOSER UP.
- D 28.9.16 FRONT OF HOUSE LAYOUT UPDATED. LOCKER/APP AREA ADDED. NEW BEVERAGE FETER DOOR ADDED TO BEER.
- 14.9.16 KITCHEN LAYOUT UPDATED. FOL LAYOUT UPDATED. BAR KITCHEN WALL MOVED UP 3.5mm. BAR/SERVE BENCH OF BAR AND BACK OF KITCHEN ASSEMBLED. LOCKERS REMOVED. 3 CIRCLES TO STAFF STAIRWELL. FLOOR RECESS TO KITCHEN-SMOKER DOOR.
- B 28.04.16 SHOW KITCHEN LAYOUT REPORTED. DOOR MOVING TO SERVICE INCL. SERVICE BAR DOOR REVISED AS LATER SURVEY. LOCKER NOTES ADDED.
- A 21.04.16 SHOWS DRAWING ADDED. MAKE CLEARANCE AREAS ADDED. SCREEN BINS ADDED.

Rev	Date	Comments
PRELIMINARY		
Client: KNBY LIND OP3		
Project: BEV RESTAURANT LEVEL 3 LEADENHALL BUILDING		

Project No.	Date
5629	MAR 2016
Drawing No.	Revision
5629-1-101	O
Scale	Drawn
AS SHOWN @ A1	RC
	Check
	RC

- THE FOLLOWING ITEMS ARE TO BE SUPPLIED BY CLIENT:**
- VITRINE SHELVING
 - OFFICE FURNITURE
 - LOCKERS
 - CHANGING ROOM BENCHES
 - NOTICEBOARDS

FLOOR PLAN
SCALE 1:100

Hepler House, Leadenhall Street, Watlington Heath, East. D68736
 phone: 01753 752083
 fax: 01753 752084
 info@offisatarchitects.co.uk
 www.offisatarchitects.co.uk