




Ground Level

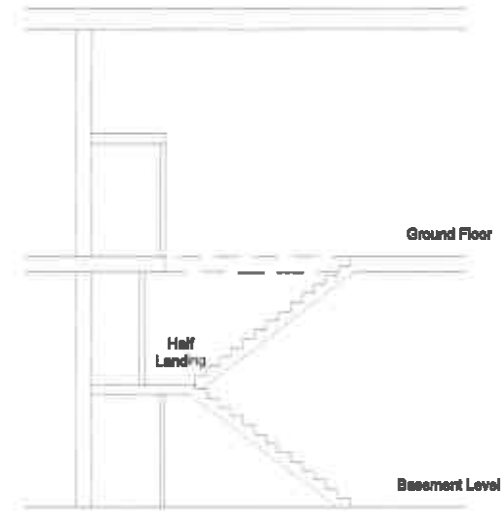

Half Landing

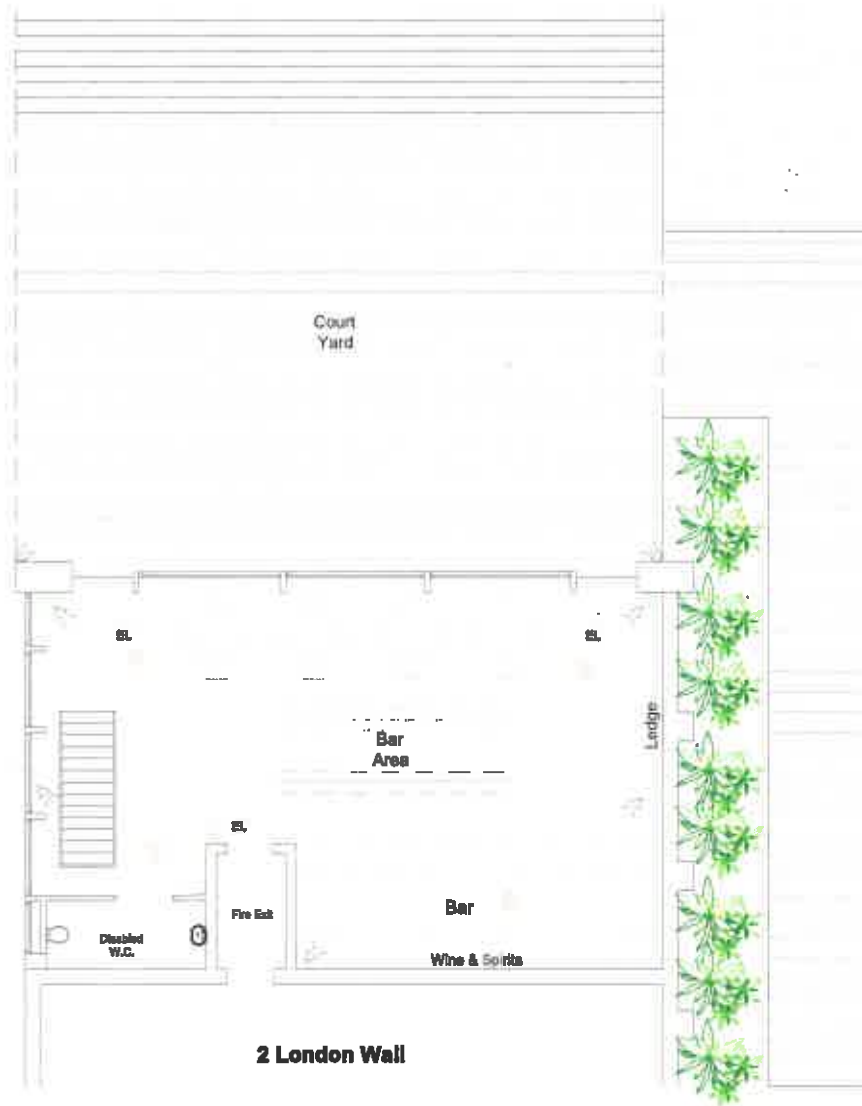

Basement Level

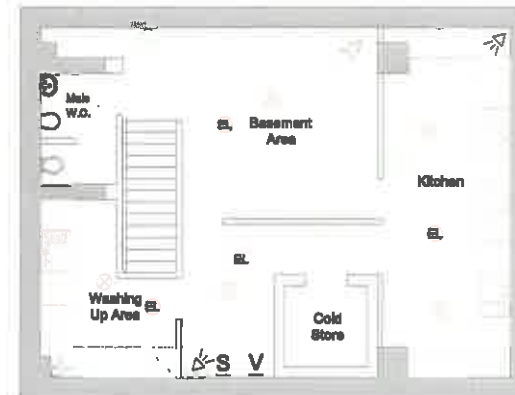

NOTES:

Proposed - Floor Plans

Security Camera

Monitors

Video Recording Equipment

Smoke/Heat Detector

Emergency Light

Fire Alarm Switch Board

Fire Alarm panel



Contact:

Tel: 02070 628 720

Email: joel.gray@greatplans.co.uk

Client:

Location:

2 London Wall Place
London
EC2Y 5AU

Scale: 1:100 A3

0 1M 5M



Date:

10-04-18

Drawn By:

Joel Gray

Dwg No:

01

