


Basement Floor Plan

PETER KNIGHT M.C.I.A.T. A.B.Eng. CHARTERED ARCHITECTURAL TECHNOLOGIST 10 Hamilton Place, Clarendon way, Colchester, Essex, CO1 1XF Tel: 01206 571349 Mob 07941988346 Email: plknight.ltd@gmail.com	The CAD layers used on this drg. are:-					
	SCALE 1-100 @ A3	DATE April 2023	PROJECT 18-19 Long Lane, London EC1A 9PL	DRG. TITLE Basement	JOB No 332	DRG. No

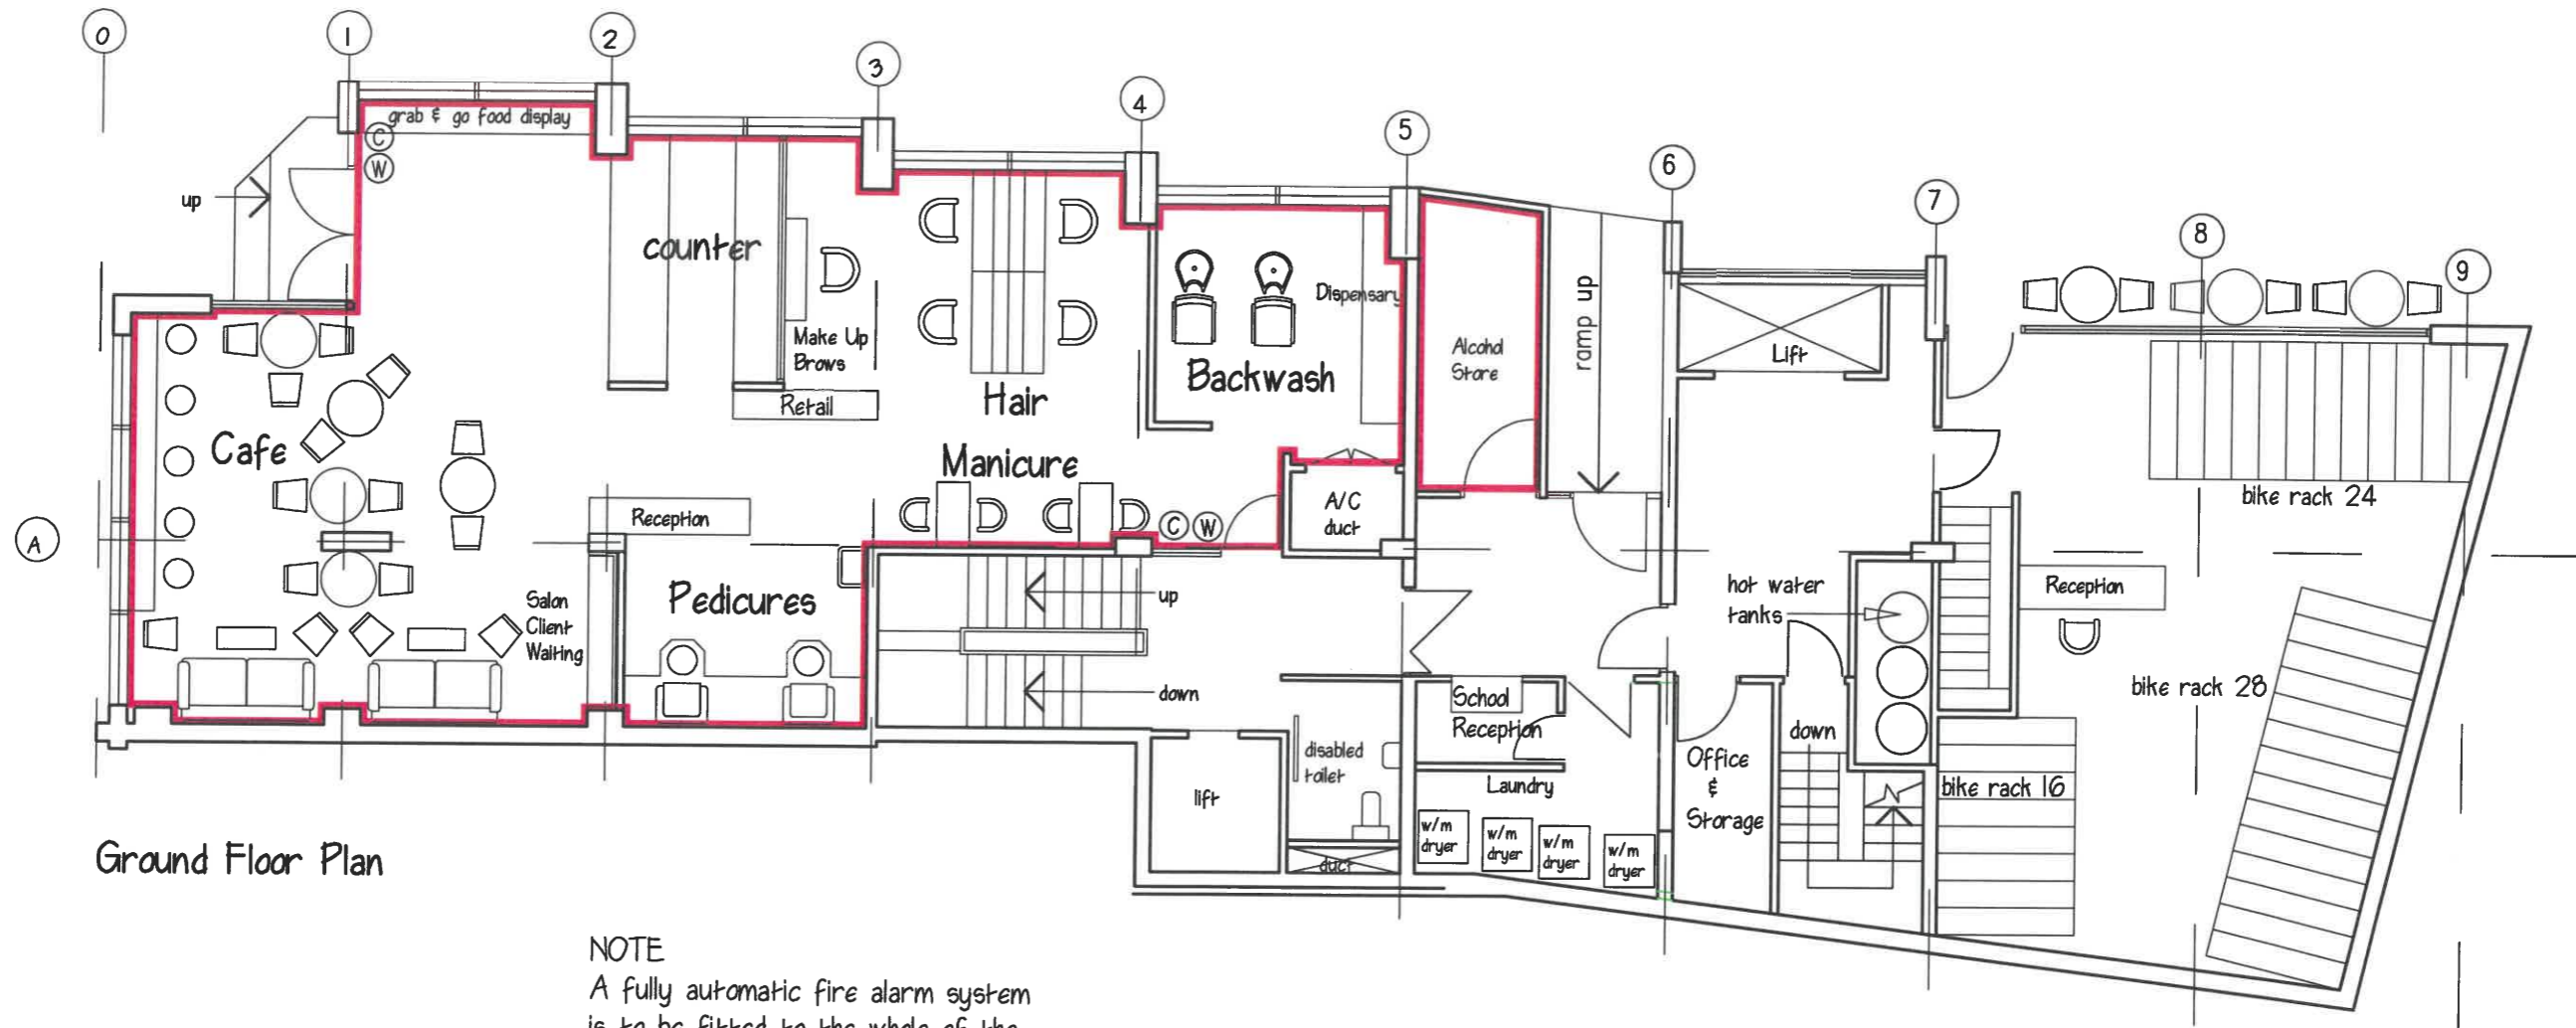

Ground Floor Plan


NOTE
 A fully automatic fire alarm system is to be fitted to the whole of the function area in accordance with BS 5839-1: 2002.

Emergency lighting is to be installed to the whole of the building in accordance with BS 5266-1: 2005

- Ⓜ Water Extingisher
- Ⓢ Carbon Dioxide Extingisher

— area for licensable activities


loose furniture shown as indicative only

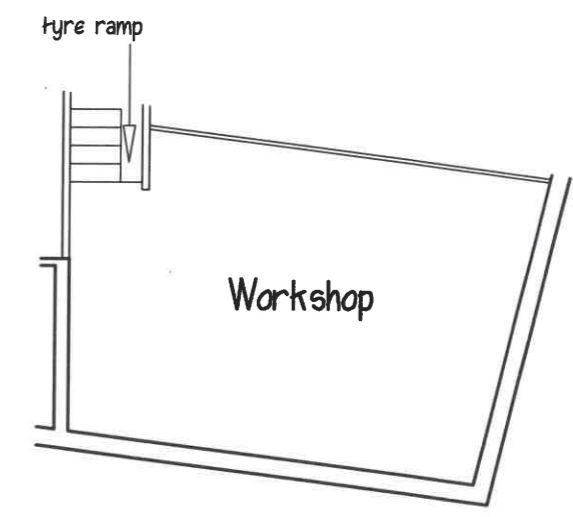


Ground Floor Mezzanine

PETER KNIGHT M.C.I.A.T. A.B.Eng.
CHARTERED ARCHITECTURAL TECHNOLOGIST
 10 Hamilton Place, Clarendon way, Colchester, Essex, CO1 1XP
 Tel: 01206 571349 Mob 07941988346 Email: pknight1td@gmail.com

 The CAD layers used on this drg. are:-



SCALE	DATE	PROJECT	DRG. TITLE	JOB No	DRG. No	REV.
1-100 @ A3	May 2023	18-19 Long Lane, London EC1A 9PL	Ground Floor Plan	349	1	

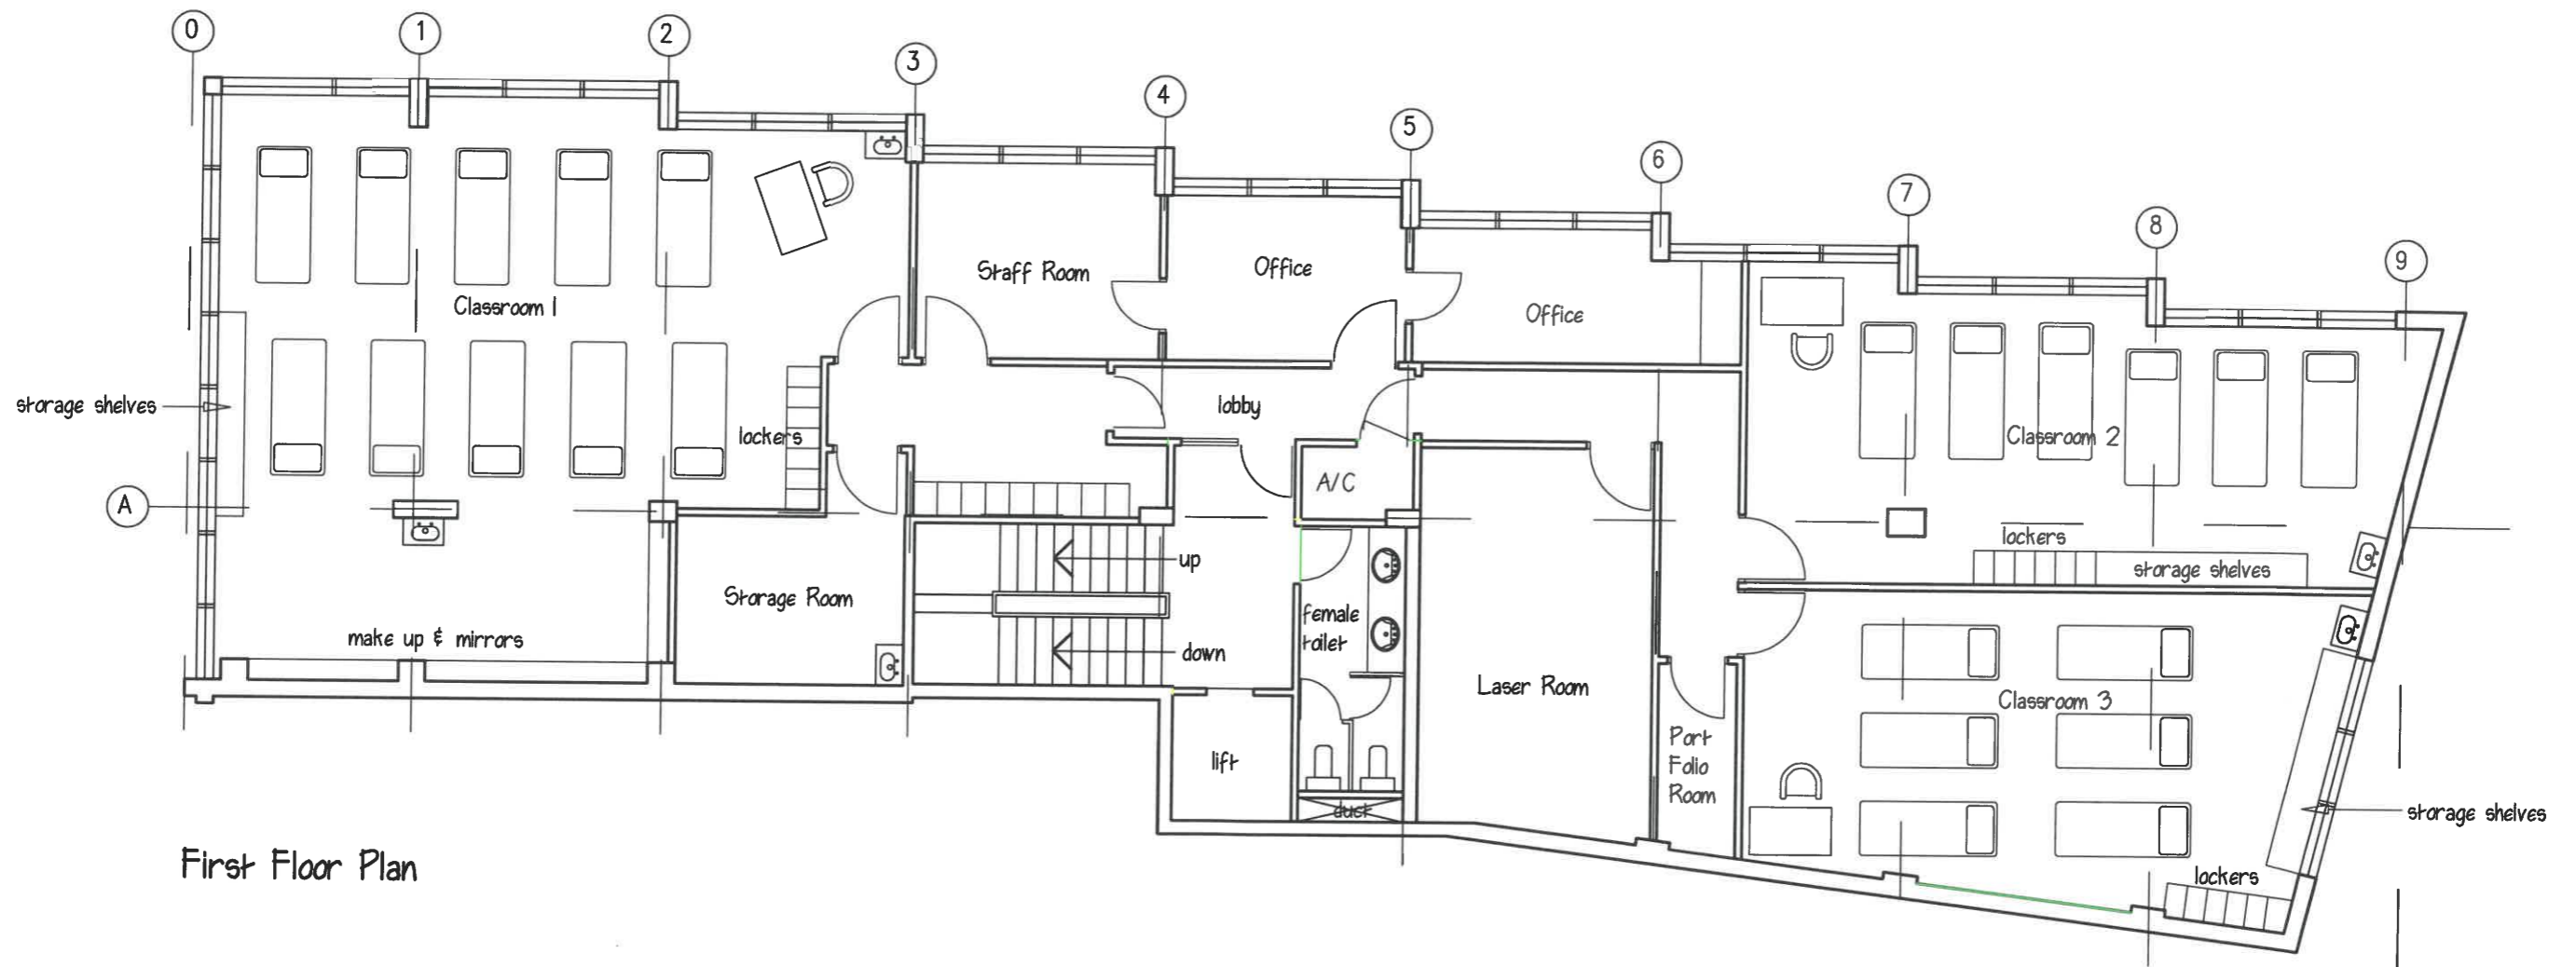


First Floor Plan


PETER KNIGHT M.C.I.A.T. A.B.Eng.
CHARTERED ARCHITECTURAL TECHNOLOGIST

10 Hamilton Place, Clarendon way, Colchester, Essex, CO1 1XP
 Tel: 01206 571349 Mob 07941988346 Email: pknight.ltd@gmail.com

 The CAD layers used on this drg. are:-




SCALE 1-100 @ A3	DATE April 2023	PROJECT 18-19 Long Lane, London EC1A 9PL	DRG. TITLE 1st Floor Plan	JOB No 332	DRG. No	REV.
----------------------------	---------------------------	--	-------------------------------------	----------------------	----------------	-------------

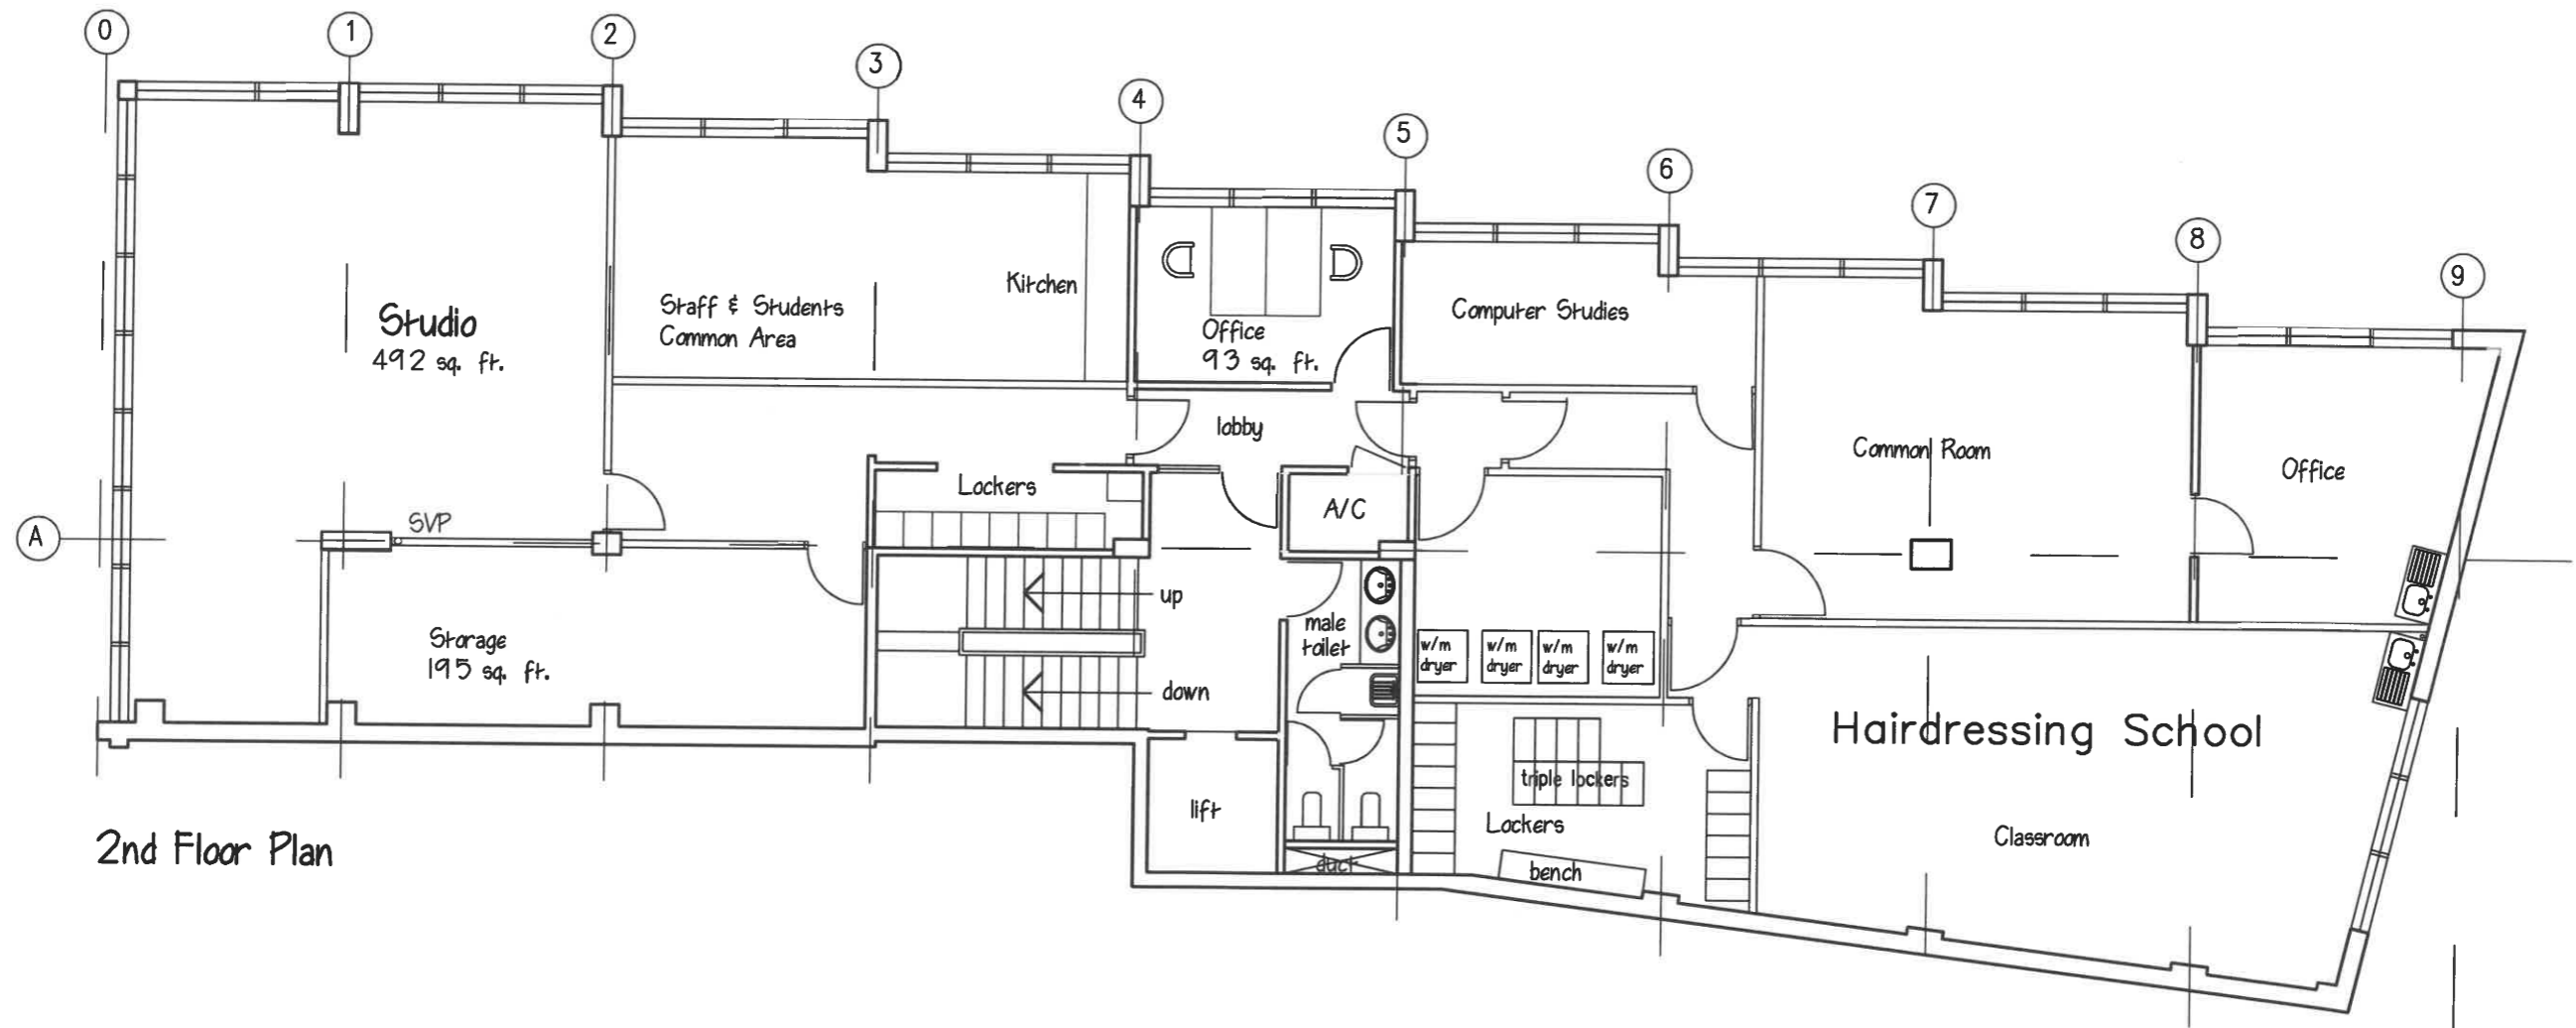

2nd Floor Plan

PETER KNIGHT M.C.I.A.T. A.B.Eng. CHARTERED ARCHITECTURAL TECHNOLOGIST 10 Hamilton Place, Clarendon way, Colchester, Essex, CO1 1XF Tel: 01206 571349 Mob 07941988346 Email: plknight.ltd@gmail.com	The CAD layers used on this drg. are:-					
	SCALE 1-100 @ A3	DATE April 2023	PROJECT 18-19 Long Lane, London EC1A 9PL	DRG. TITLE 2nd Floor Plan	JOB No 332	DRG. No

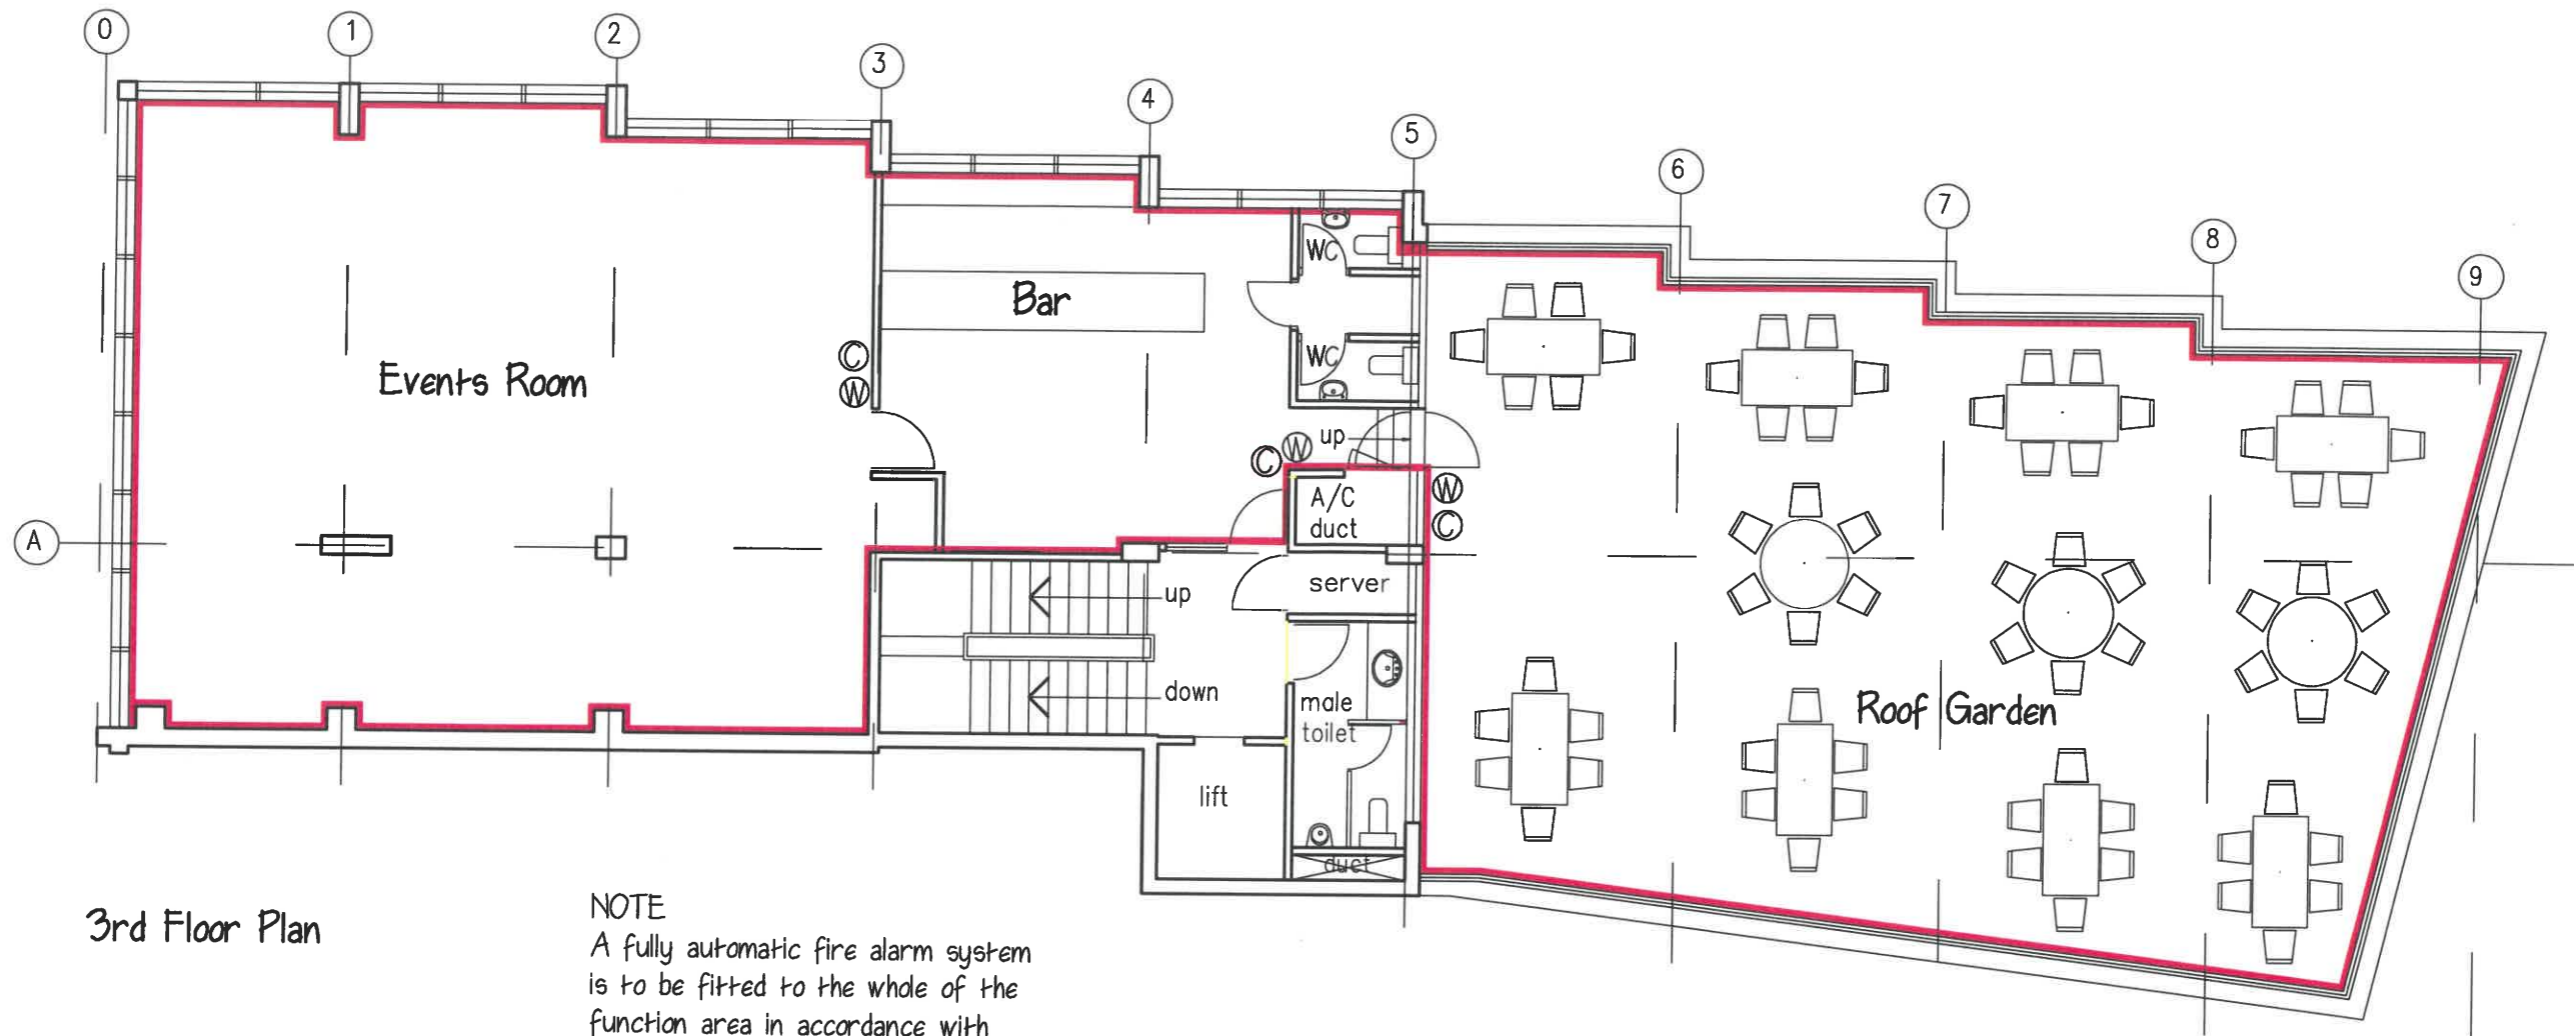

3rd Floor Plan

NOTE
 A fully automatic fire alarm system is to be fitted to the whole of the function area in accordance with BS 5839-1: 2002.

Emergency lighting is to be installed to the whole of the building in accordance with BS 5266-1: 2005

 
- Ⓜ Water Extingisher
- ⓐ Carbon Dioxide Extingisher

— area for licensable activities



loose furniture shown as indicative only

PETER KNIGHT M.C.I.A.T. A.B.Eng.
CHARTERED ARCHITECTURAL TECHNOLOGIST
 10 Hamilton Place, Clarendon way, Colchester, Essex, CO1 1XF
 Tel: 01206 571349 Mob 07941988346 Email: pknight.ltd@gmail.com

The CAD layers used on this drg. are:-



SCALE	DATE	PROJECT	DRG. TITLE	JOB No	DRG. No	REV.
1-100 @ A3	May 2023	18-19 Long Lane, London EC1A 9PL	3rd Floor Plan	349	2	

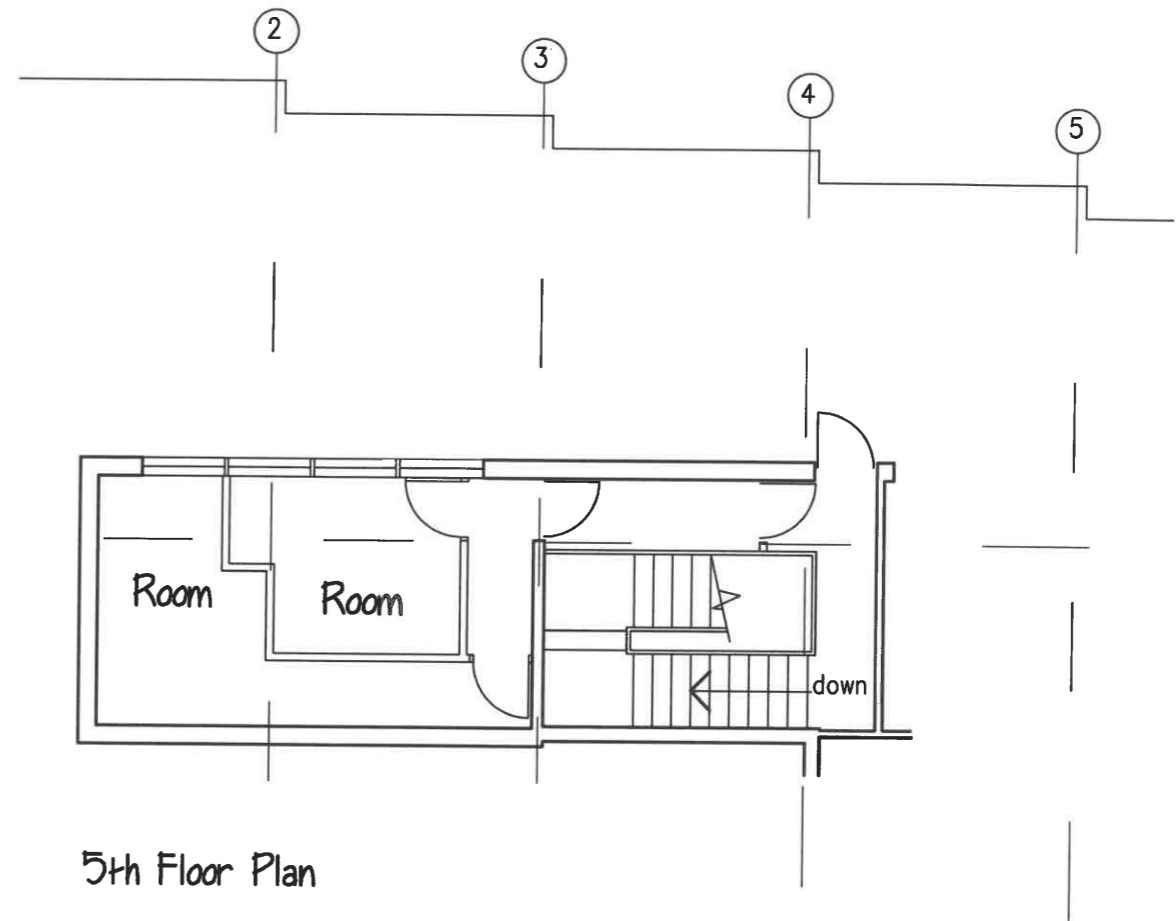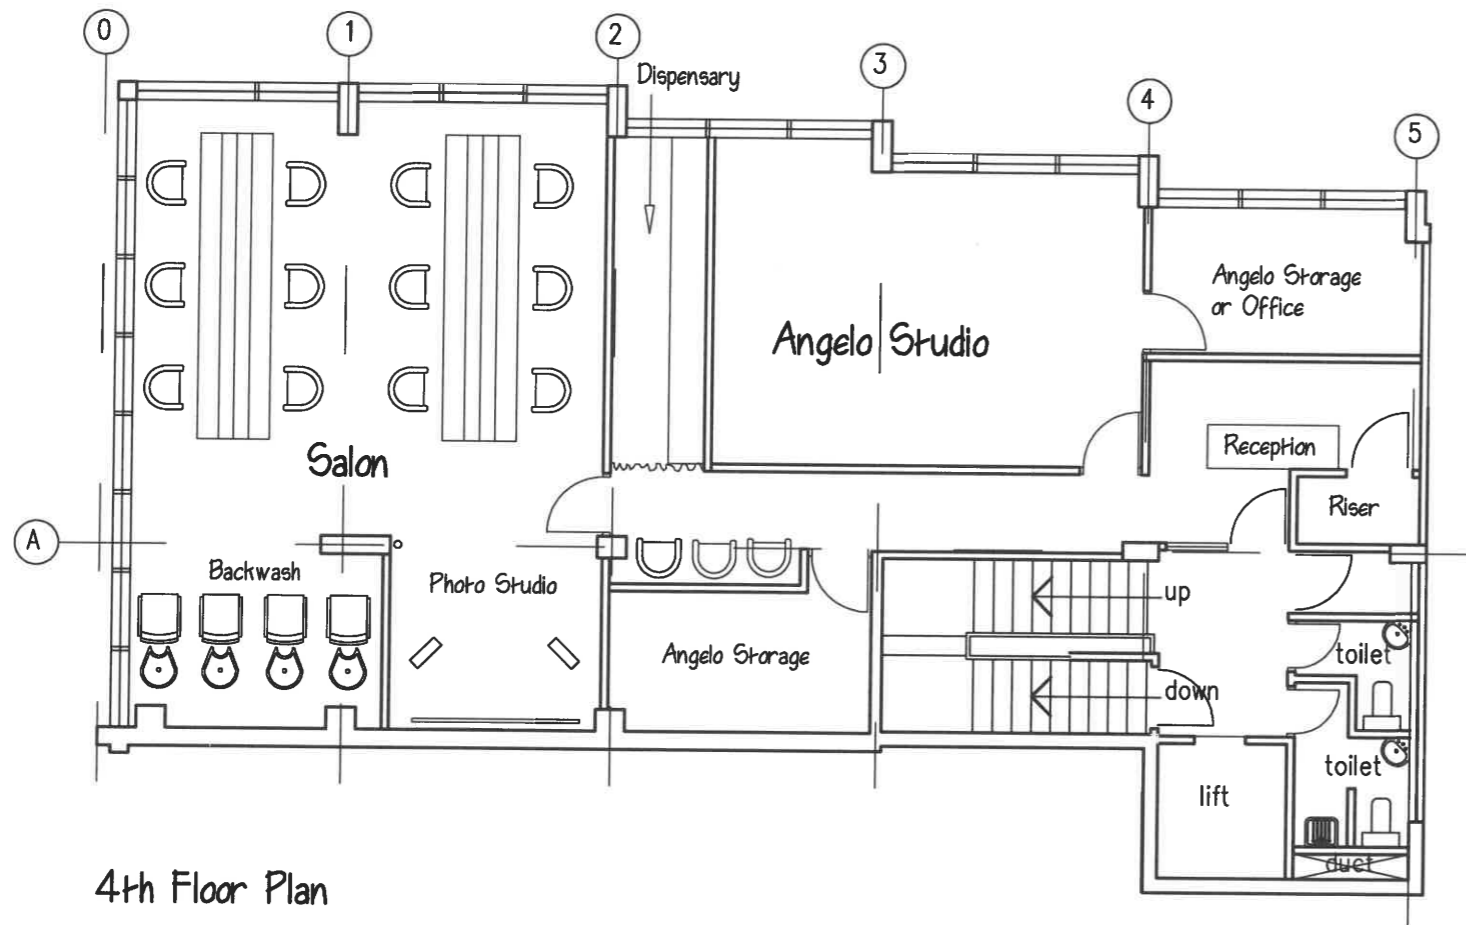

PETER KNIGHT M.C.I.A.T. A.B.Eng.
CHARTERED ARCHITECTURAL TECHNOLOGIST
 10 Hamilton Place, Clarendon way, Colchester, Essex, CO1 1XF
 Tel: 01206 571349 Mob 07941988346 Email: pknigh1.ttd@gmail.com

The CAD layers used on this drg. are:-

SCALE	DATE	PROJECT	DRG. TITLE	JOB No	DRG. No	REV.
1-100 @ A3	April 2023	18-19 Long Lane, London EC1A 9PL	4th & 5th Floors	332		

0 1 2 3 4 5